

# 117 St. Botolph St. #2

2/6/19


## LIST OF DRAWINGS

- A1 REFERENCE
- A2 FLOOR PLANS
- A3 EXTERIOR ELEVATIONS



117 St. Botolph Street #2  
Cover



PUBLIC ALLEY 403

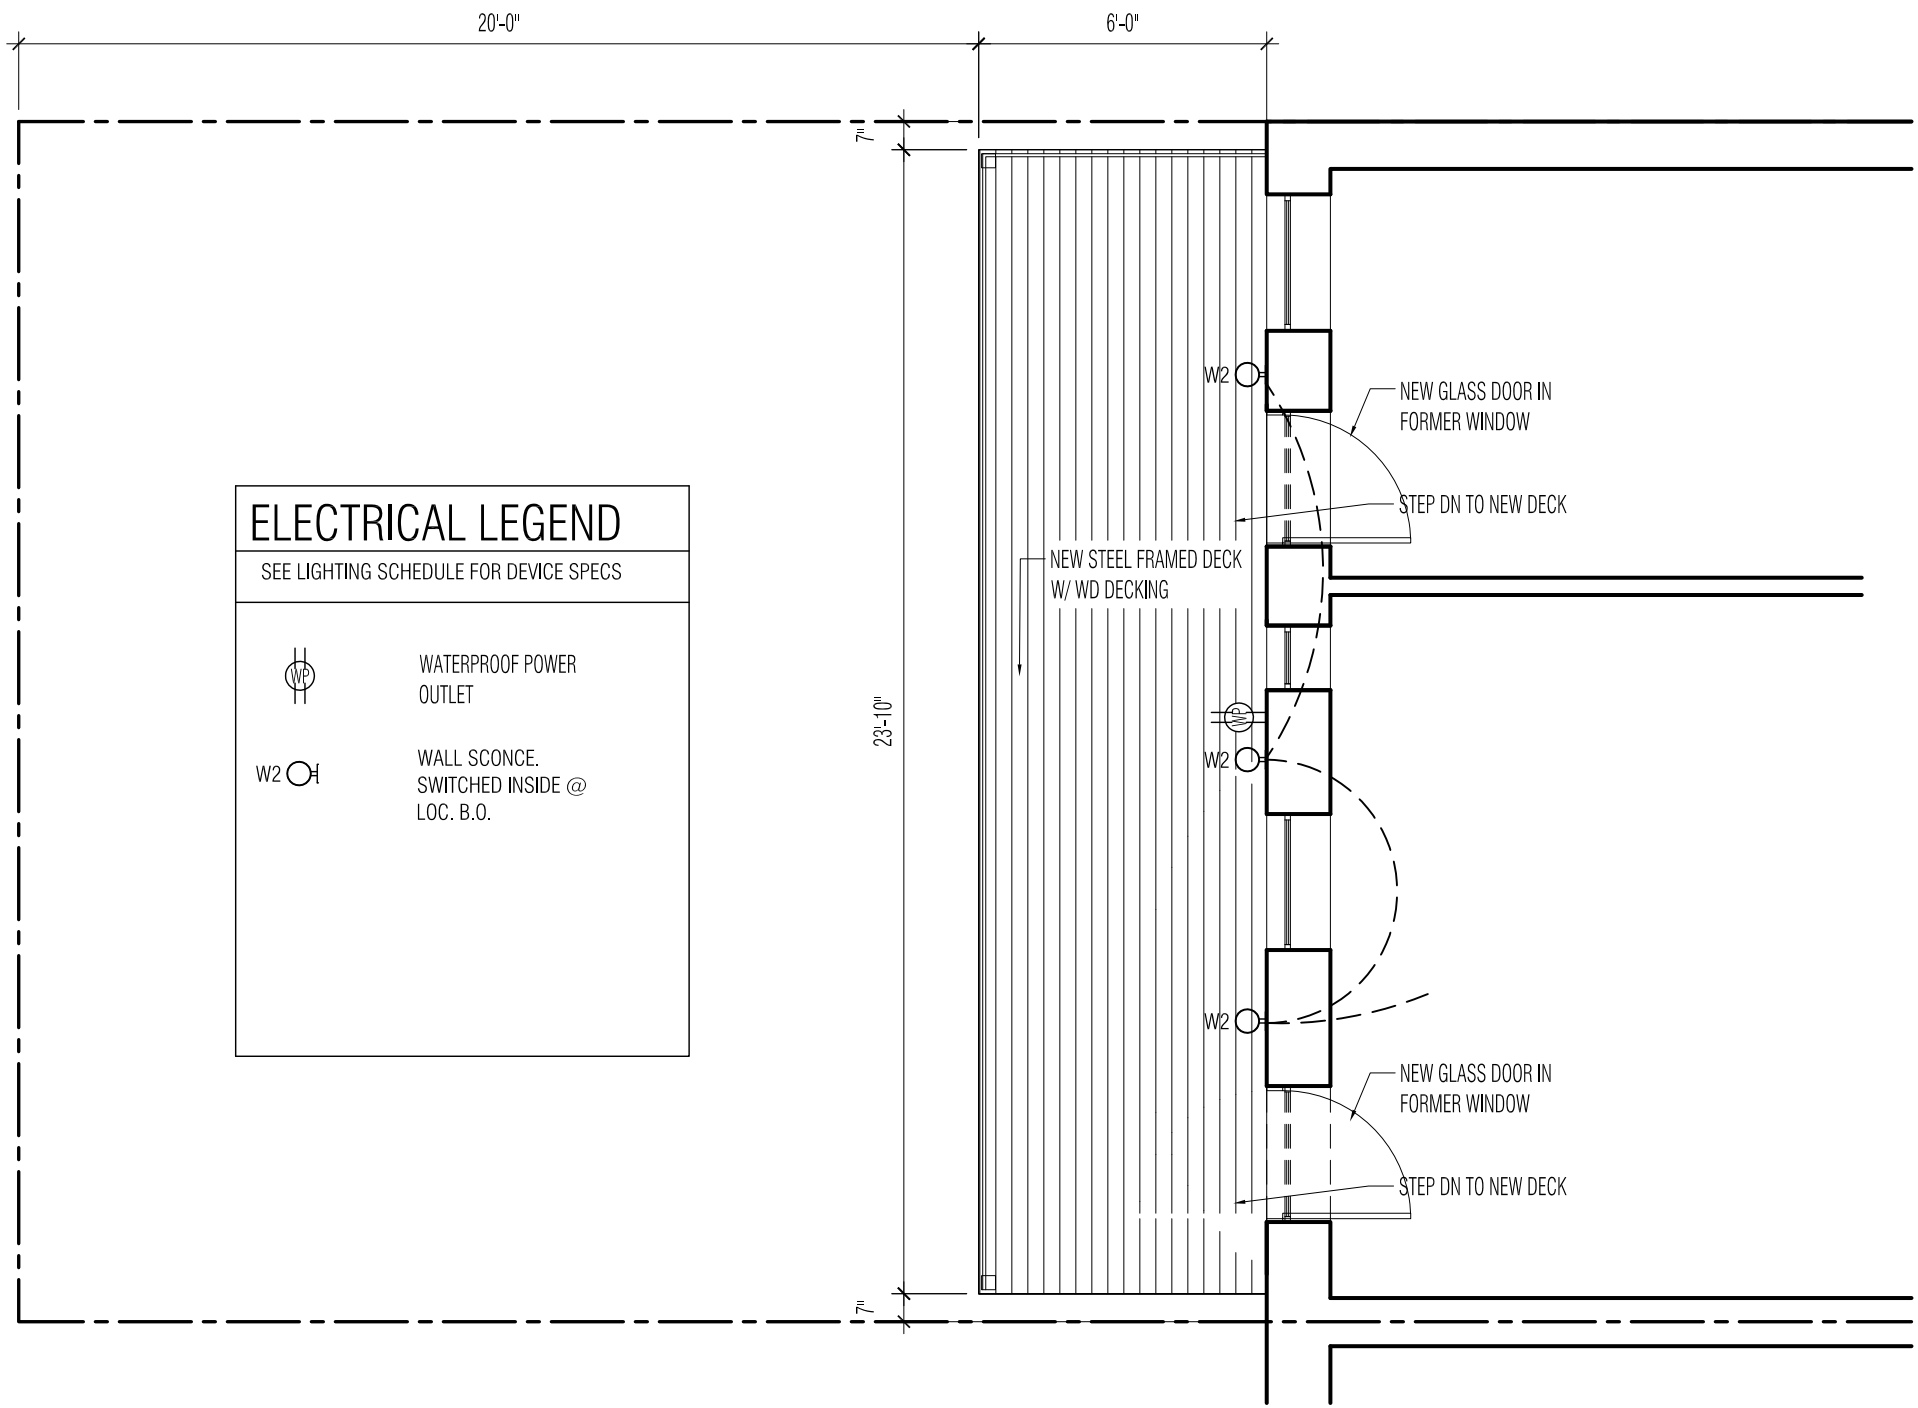

ELECTRICAL LEGEND	
SEE LIGHTING SCHEDULE FOR DEVICE SPECS	
	WATERPROOF POWER OUTLET
W2	WALL SCONCE. SWITCHED INSIDE @ LOC. B.O.

**1** SECOND FLOOR PLAN  
scale: 1/4" = 1'-0"

117 St. Botolph Street #2  
Proposed Second Level Plan

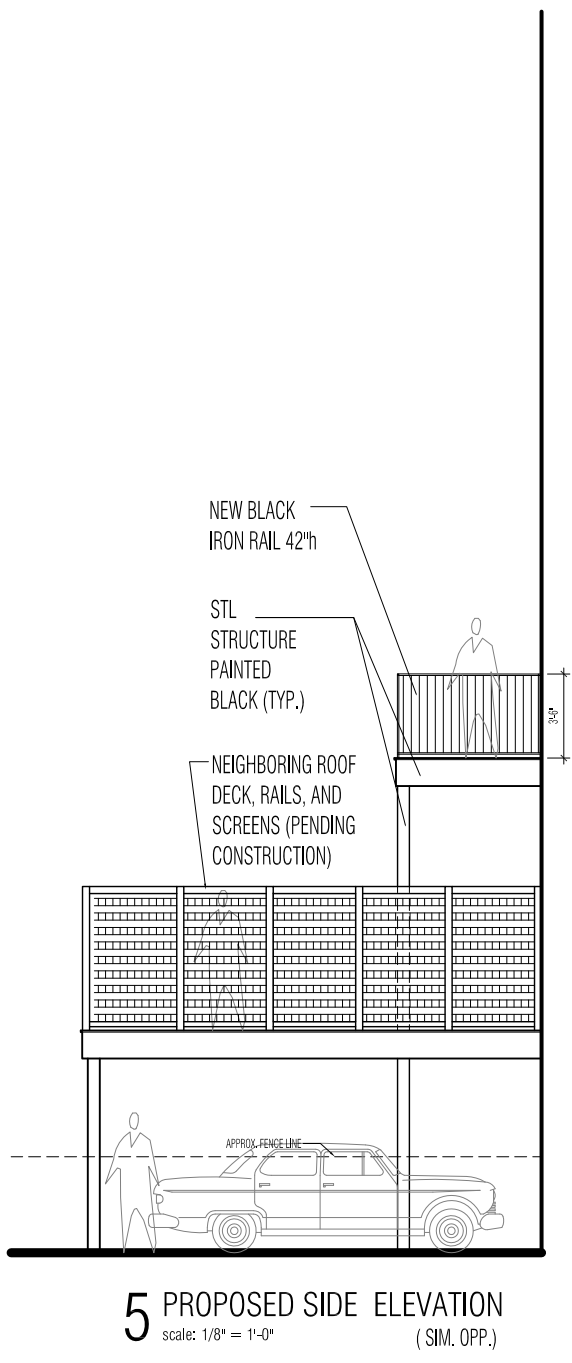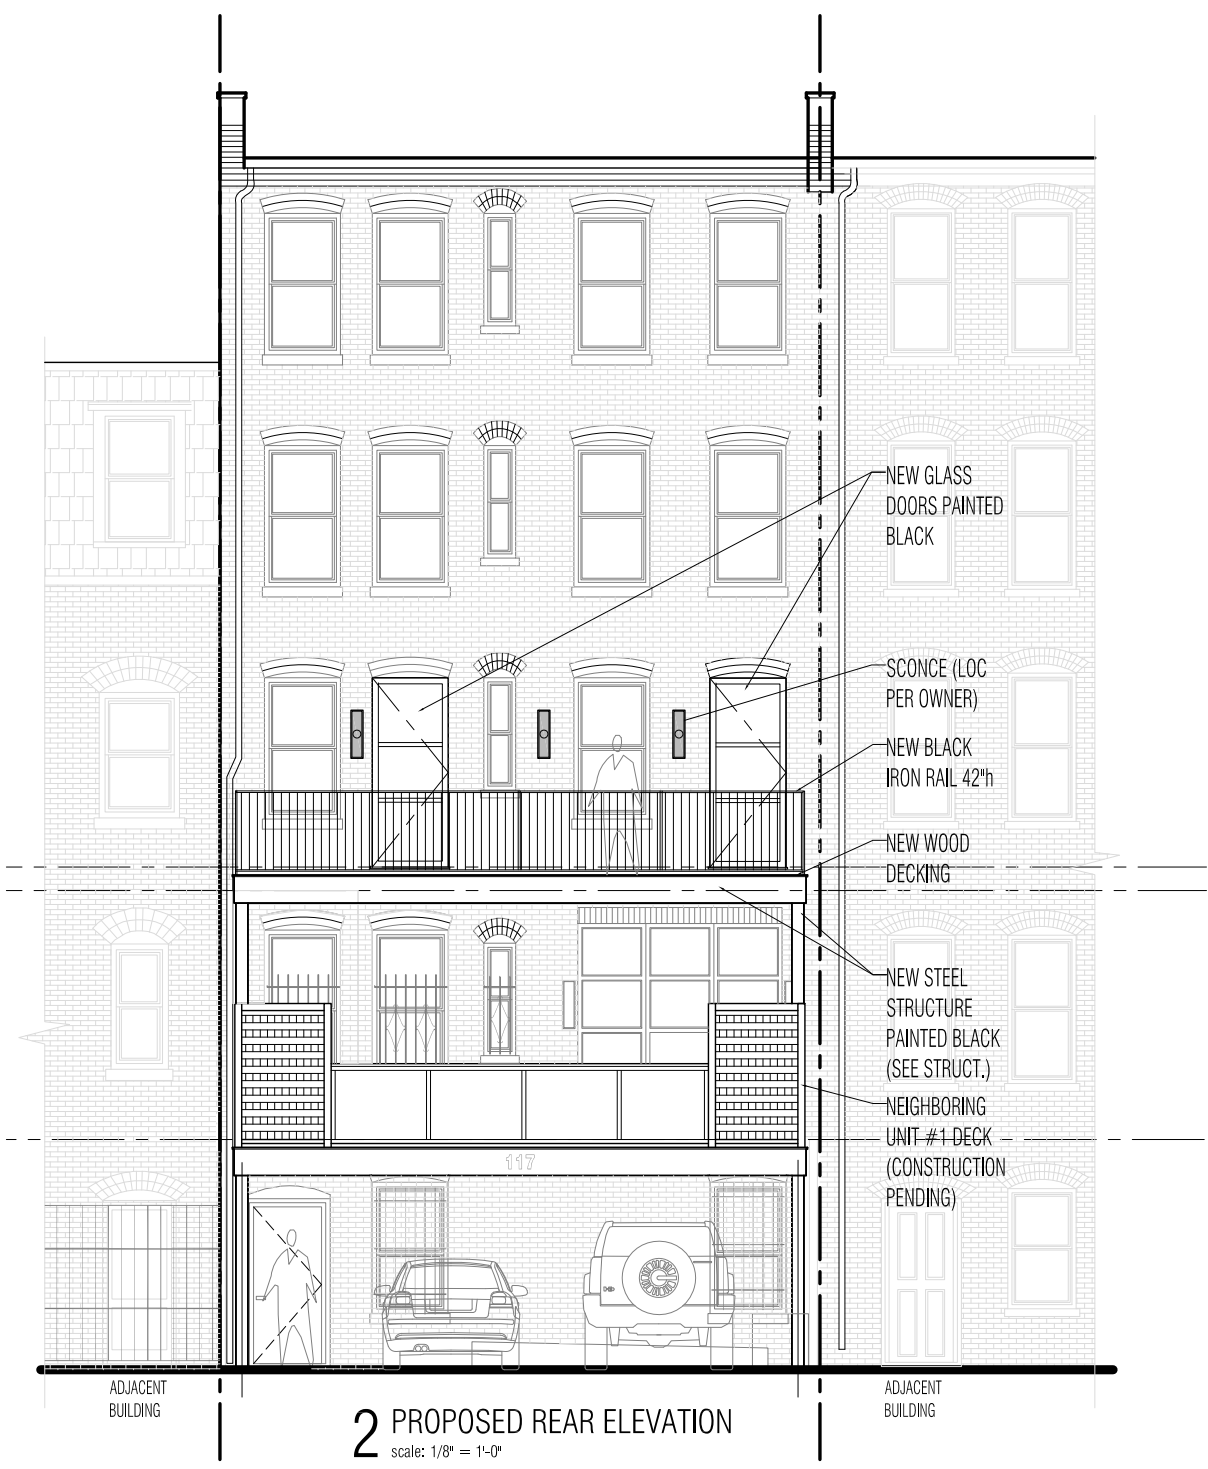

117 St. Botolph Street #2  
**Rear Elevations- Existing and Proposed**